



LAMINADOS CHINOS

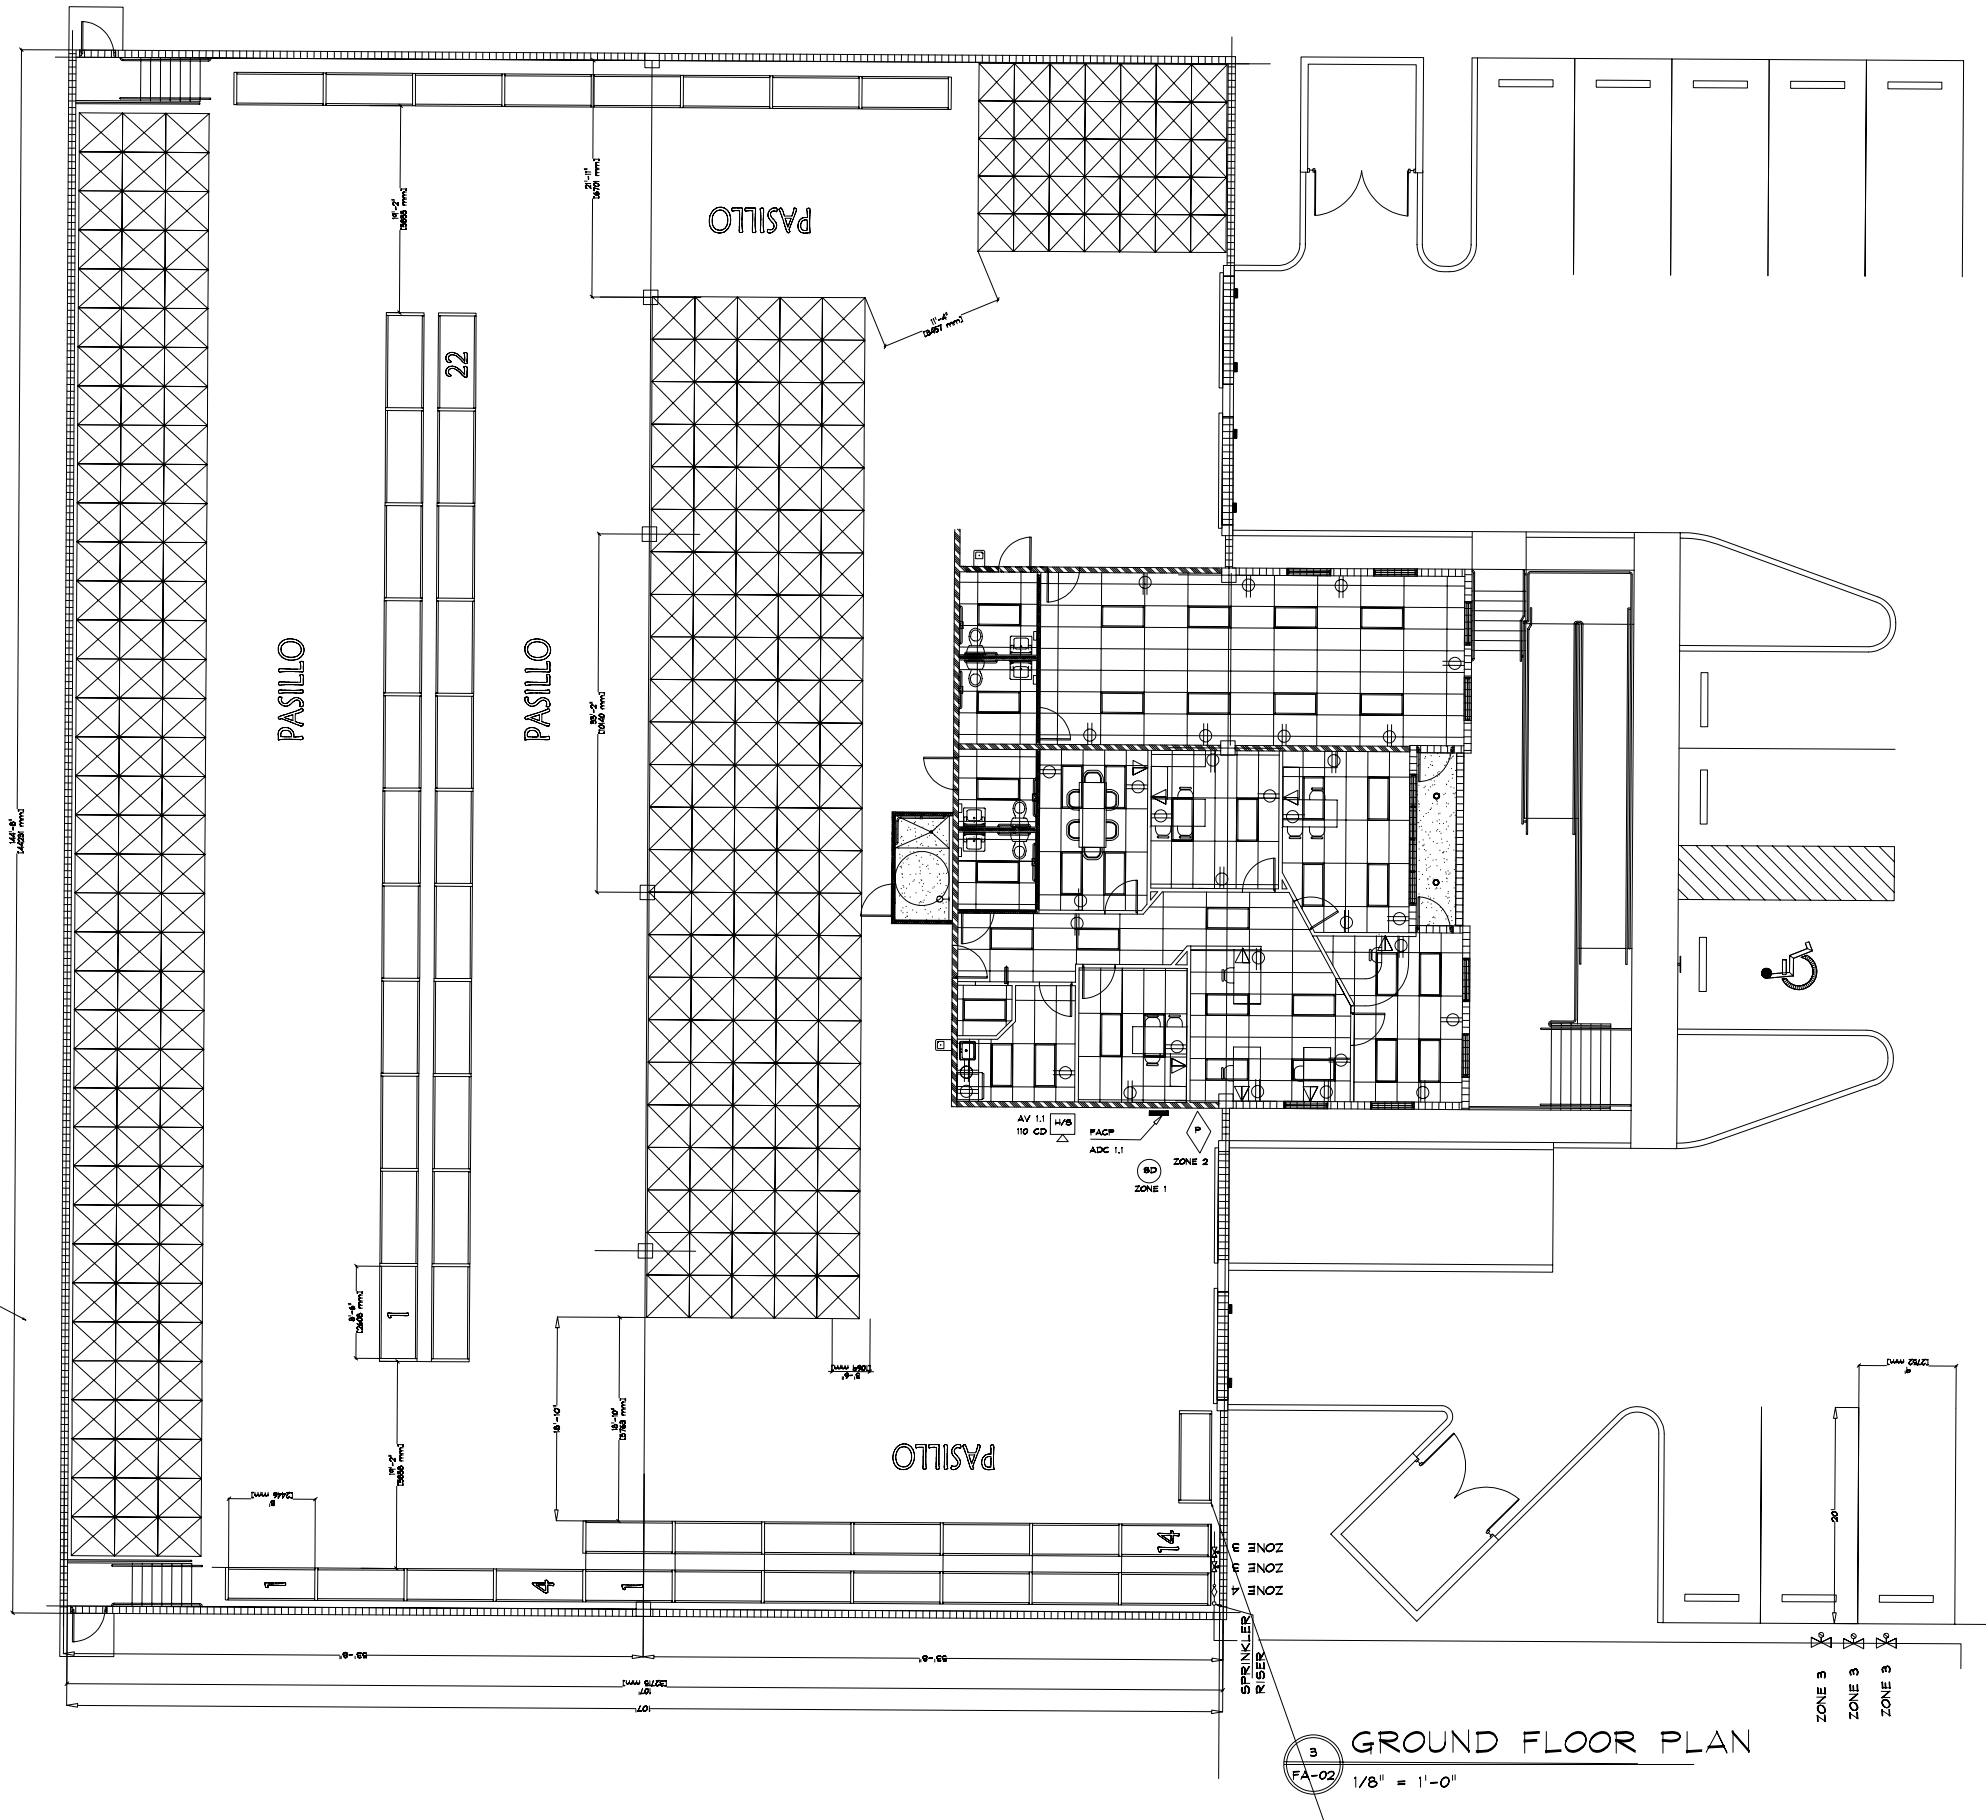

3
 FA-02
 GROUND FLOOR PLAN
 1/8" = 1'-0"

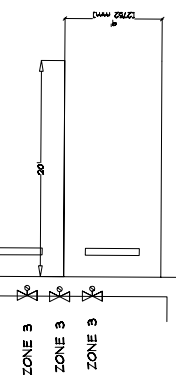

MiamiArt
 FRANK NARANJO
 ENGINEERING CONSULTANT
 1310 WEST 95 STREET
 HIALEAH, FL 33012-4829
 PHONE (305) 819-4809
 EMAIL FRANK@NUBEUS.COM

PROJECT NAME:
EASTPOINT SUPPLIERS, Inc
 PROJECT NUMBER:
EASTPOINT SUPPLIERS
 11001 NW 123 STREET
 MEDLEY, FLA 33178

HS HORIZON SECURITY SYSTEMS, INC.
 A DIVISION OF HORIZON ELECTRONICS, INC.
 TELEPHONE 305-362-6767
 14050 N.W. 82ND AVENUE
 MIAMI LAKES, FLORIDA 33016

DRAWING TITLE:
 Ground Floor Plan
 Fire Alarm License:
Jorge T. Tapanes Jr.
 STATE CONTRACTOR
 LICENSE #EF-0000530

DRAWN BY: FN
 Monday, October 30, 2006
 APPROVED BY: JTT
 J.T. TAPANES JR.

SHEET NO.
FA-03
 OF
4