


C:\PROJECTS\HORIZON BIDS\DP NEW SUPERVISORY\10-20-06\HAVANA PLAZA 10-03-06 0332.DWG, 01 COVER, 10/19/2006
 FN, A:ROBAT PDFWRITER, LETTER [8.5 x 11 IN], I:3.26298, FRANK NARANJO, ENGINEERING CONSULTANT

INSTALL NEW FIRE ALARM SYSTEM

HORIZON SECURITY SYSTEMS
 14050 N.W. 82ND AVENUE
 MIAMI LAKES, FLORIDA 33016
 TELEPHONE 305-362-6767

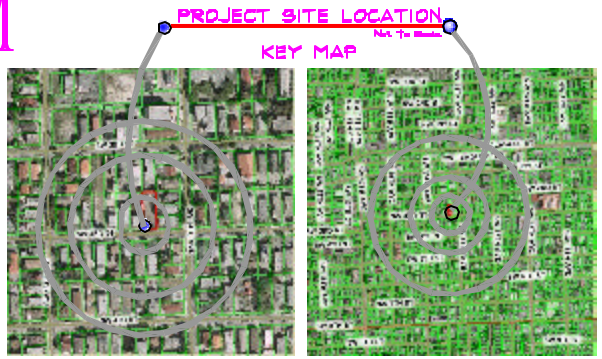

CRYSTAL BREEZE APARTMENTS 1421 SW 3rd STREET MIAMI, FLORIDA 33135



REVISIONS
 1. 10/19/06
 2. 10/19/06
 3. 10/19/06
 4. 10/19/06
 5. 10/19/06
 6. 10/19/06
 7. 10/19/06
 8. 10/19/06
 9. 10/19/06
 10. 10/19/06

SCOPE OF WORK

NEW FIRE ALARM TO SUPERVISE THE SPRINKLER SYSTEM.
 3 STORY CBS CONSTRUCTION OF 10 APARTMENTS.
 6,760 S.FT. LOT AREA WITH BUILDING FOOTPRINT OF 3,540 SQ.FT.
 FACT IS LOCATED ON GROUND FLOOR UNDER COVERED GARAGE
 AREA AS SHOWN ON PLANS. A HEAT DETECTOR AND MANUAL PULL
 STATION IS PROVIDED NEAR THE FACT. A BELL IS LOCATED ON THE
 SPRINKLER SYSTEM RISER. THIS IS A REMOTE SUPERVISED STATION
 FIRE ALARM SYSTEM CONNECTED TO A U.L. LISTED CENTRAL STATION.

SHEET INDEX

FA-01 COVER SHEET
 FA-02 FLOOR PLAN, RISER, CALCS
 FA-03 DETAILS AND NOTES

SCALE: AS NOTED
 DRAWN BY: FN
 Thursday, October 19, 2006
 APPROVED BY: JTT
 J.T. TAPANEE, JR.
 LICENSE # 15102
 J.T. TAPANEE, JR.
 LICENSE # 15102

Hs HORIZON SECURITY SYSTEMS
 A DIVISION OF HORIZON ELECTRONICS, INC.
 TELEPHONE 305-362-6767
 14050 N.W. 82ND AVENUE
 MIAMI LAKES, FLORIDA 33016

CRYSTAL BREEZE APARTMENTS
 CRYSTAL BREEZE
 1421 SW 3RD STREET
 MIAMI, FL 33135

SHEET NO.
FA-01
 OF
3